


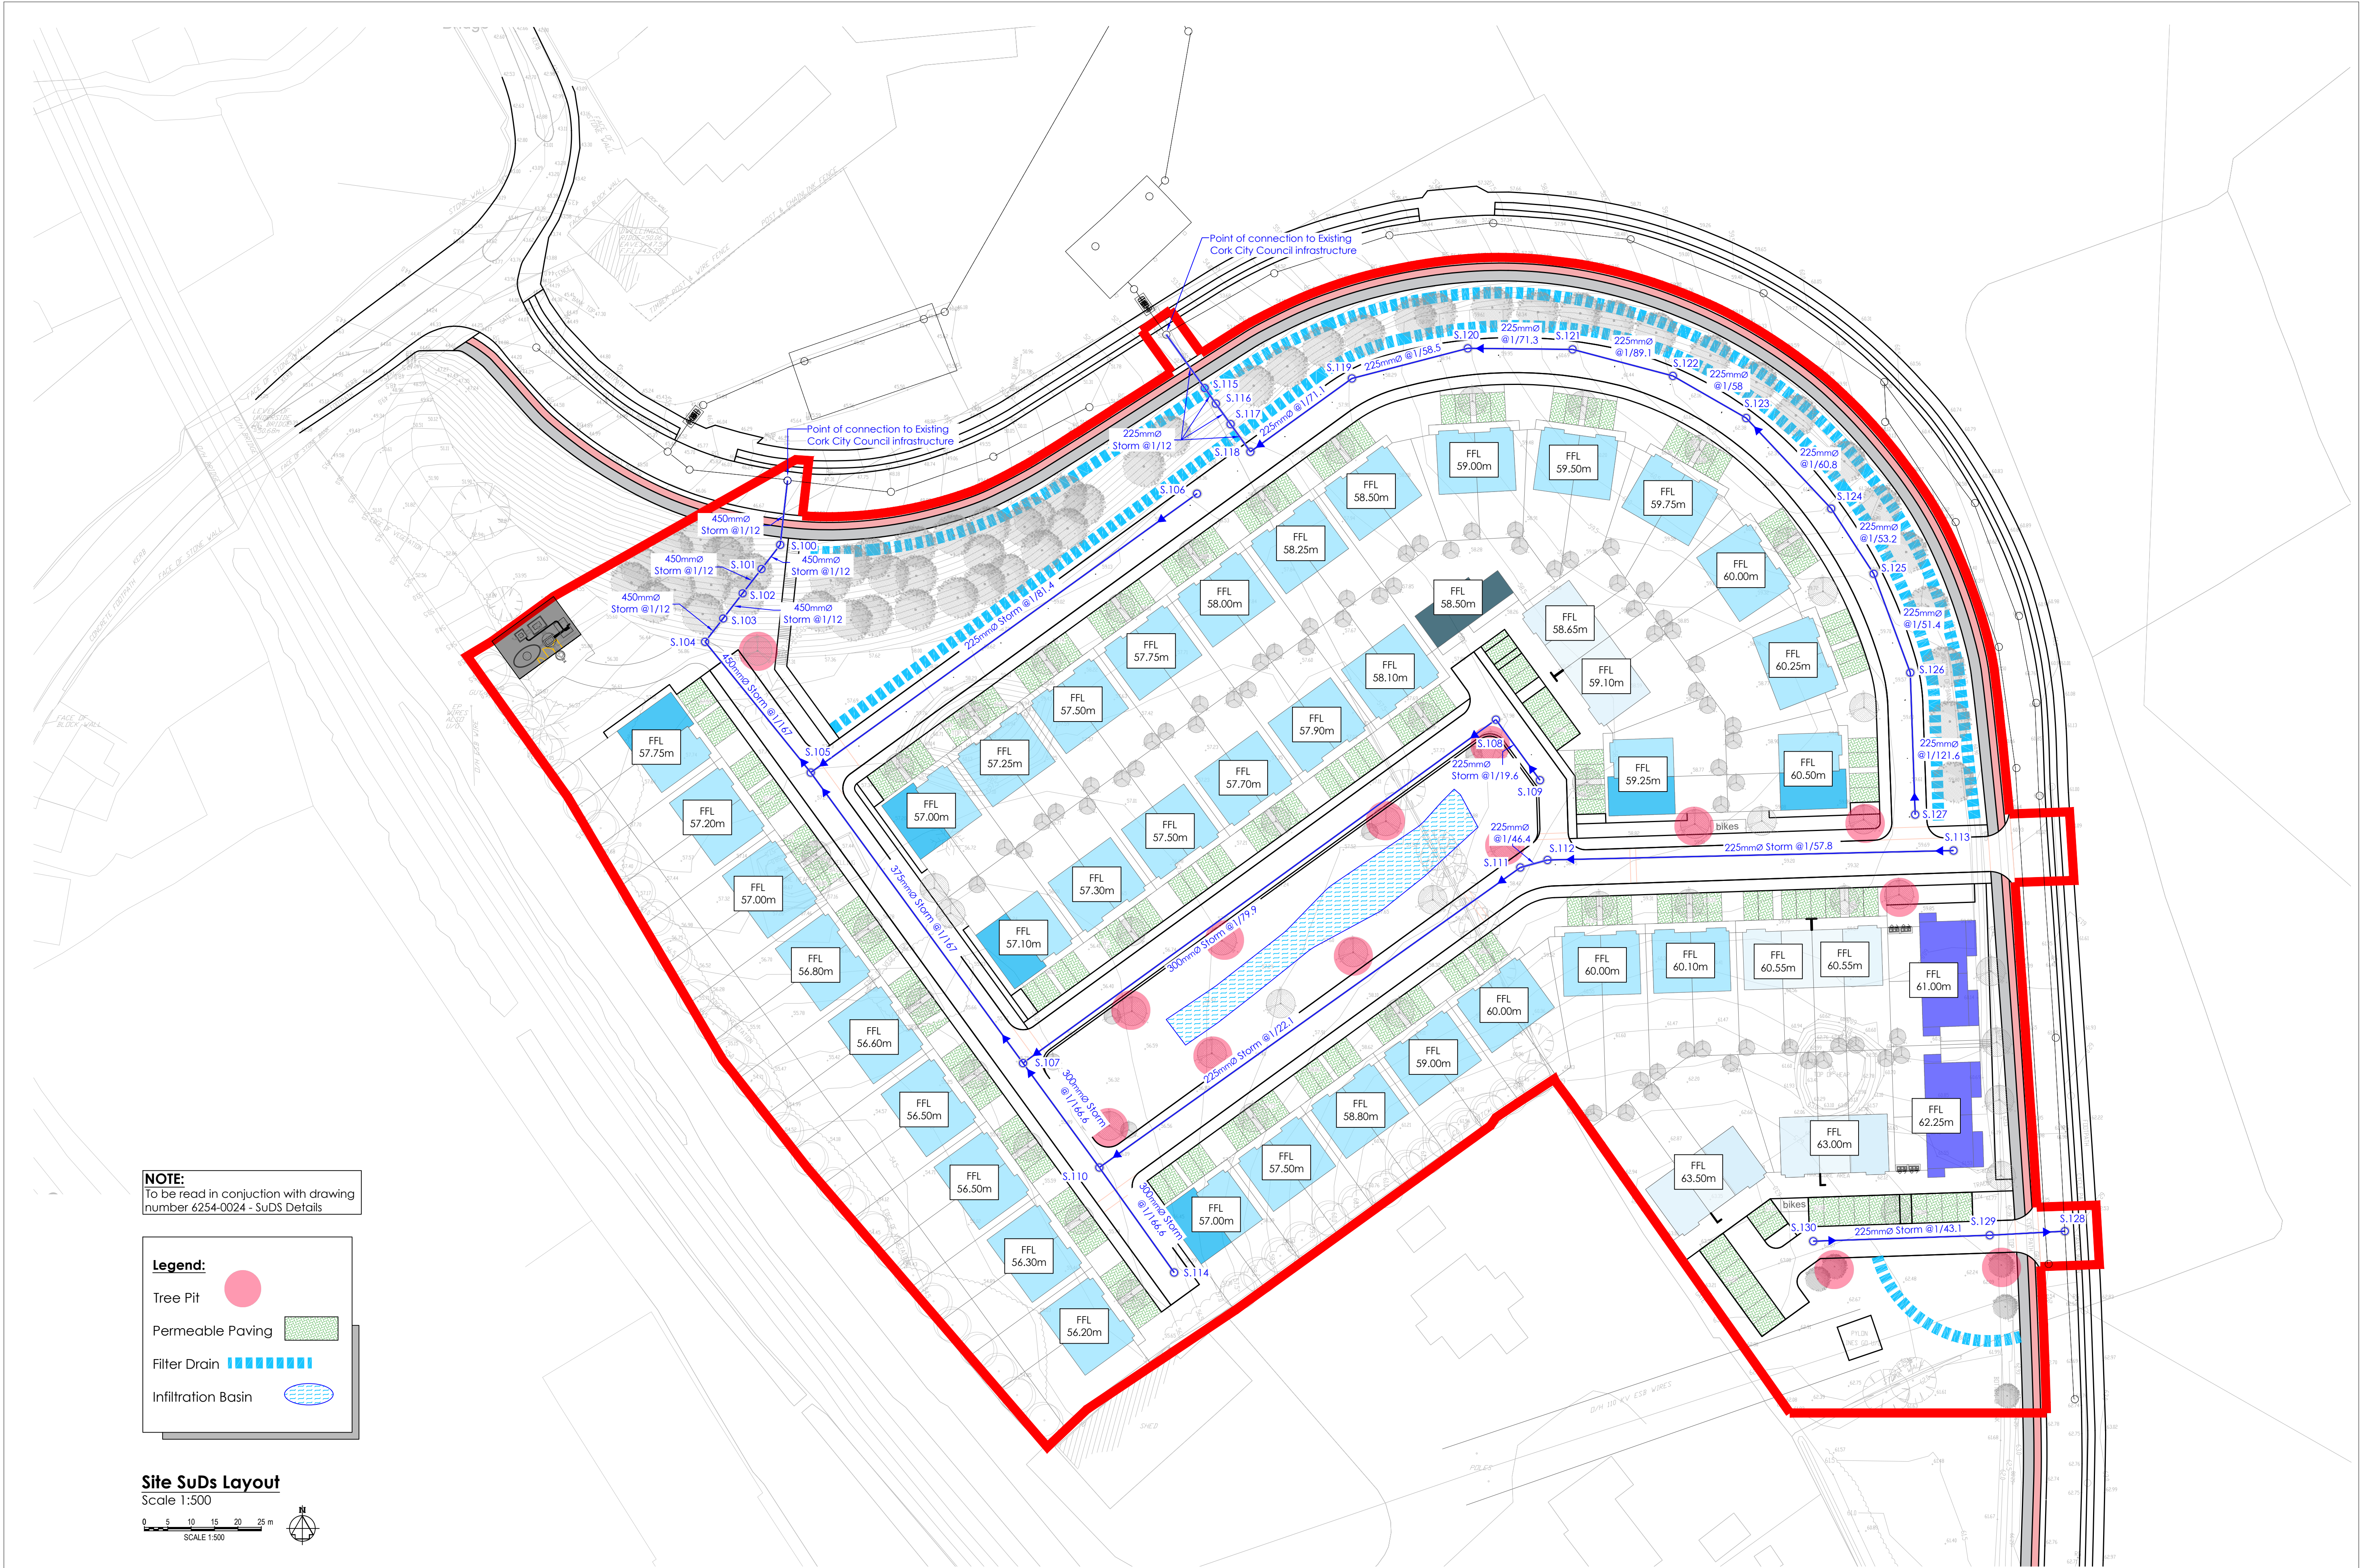

NOTE:
To be read in conjunction with drawing number 6254-0024 - SuDS Details

Legend:

- Tree Pit
- Permeable Paving
- Filter Drain
- Infiltration Basin

Site SuDs Layout
Scale 1:500



DOSA
DENIS O'SULLIVAN & ASSOCIATES
CONSULTING ENGINEERS

Joyce House
Barrack Square
Ballincollig
Cork
P31 KP84

021 4871781
info@dosa.ie
www.dosa.ie

© THIS DRAWING IS COPYRIGHT. NO PART OF THIS DOCUMENT MAY BE RE-PRODUCED OR TRANSMITTED IN ANY FORM OR STORED IN ANY RETRIEVAL SYSTEM OF ANY NATURE WITHOUT THE WRITTEN PERMISSION OF THE ENGINEER AS COPYRIGHT HOLDER EXCEPT AS AGREED FOR USE ON THE PROJECT FOR WHICH THE DOCUMENT WAS ORIGINALLY ISSUED.

REV.	DRAWN	CHKD	APPRVD	DATE	DETAILS
B	K.M.	L.O.T.	L.O.T.	25.07.24	Issued for Planning

CLIENT

PROJECT
Residential Development at Kilnap, Old Whitechurch road

DRAWING TITLE
Proposed Drainage Layout

SHEET
A1

SCALE
1:500

PROJECT NO.	DRAWING NO.	STATUS/ISSUE
6254	0023	B