

CORK CITY COUNCIL-

Proposed Residential Development at

Kilnap, Old Whitechurch road


Planning Drawings

6254-0000	Drawing Index & Locality Plan
6254-0010	Proposed Internal Road Layout & Levels
6254-0012	Proposed Sightlines Drawing
6254-0013	Proposed Speed Control Measures
6254-0014	Vehicle Tracking - Refuse Truck & Fire Tender (01 of 02)
6254-0015	Vehicle Tracking - Refuse Truck & Fire Tender (02 of 02)
6254-0020	Proposed Drainage Layout
6254-0021	Proposed Storm & Foul pipe and Manhole Schedules
6254-0022	Existing Cork City Council Infrastructure
6254-0023	Proposed SuDs Layout
6254-0024	Proposed SuDs Details
6254-0025	Proposed Wastewater Details (01 of 02)
6254-0026	Proposed Wastewater Details (02 of 02)
6254-0027	Existing Attenuation Tank Sections
6254-0028	Existing Infrastructure Upgrades
6254-0030	Proposed Watermain Layout
6254-0035	Proposed Watermain Details (01 of 02)
6254-0036	Proposed Watermain Details (02 of 02)
6254-0060	Proposed Foul Sewer Longitudinal Sections (01 of 02)
6254-0061	Proposed Foul Sewer Longitudinal Sections (02 of 02)
6254-0070	Proposed Storm Longitudinal Sections (01 of 02)
6254-0071	Proposed Storm Longitudinal Sections (02 of 02)

Drawing Index



Aerial Plan

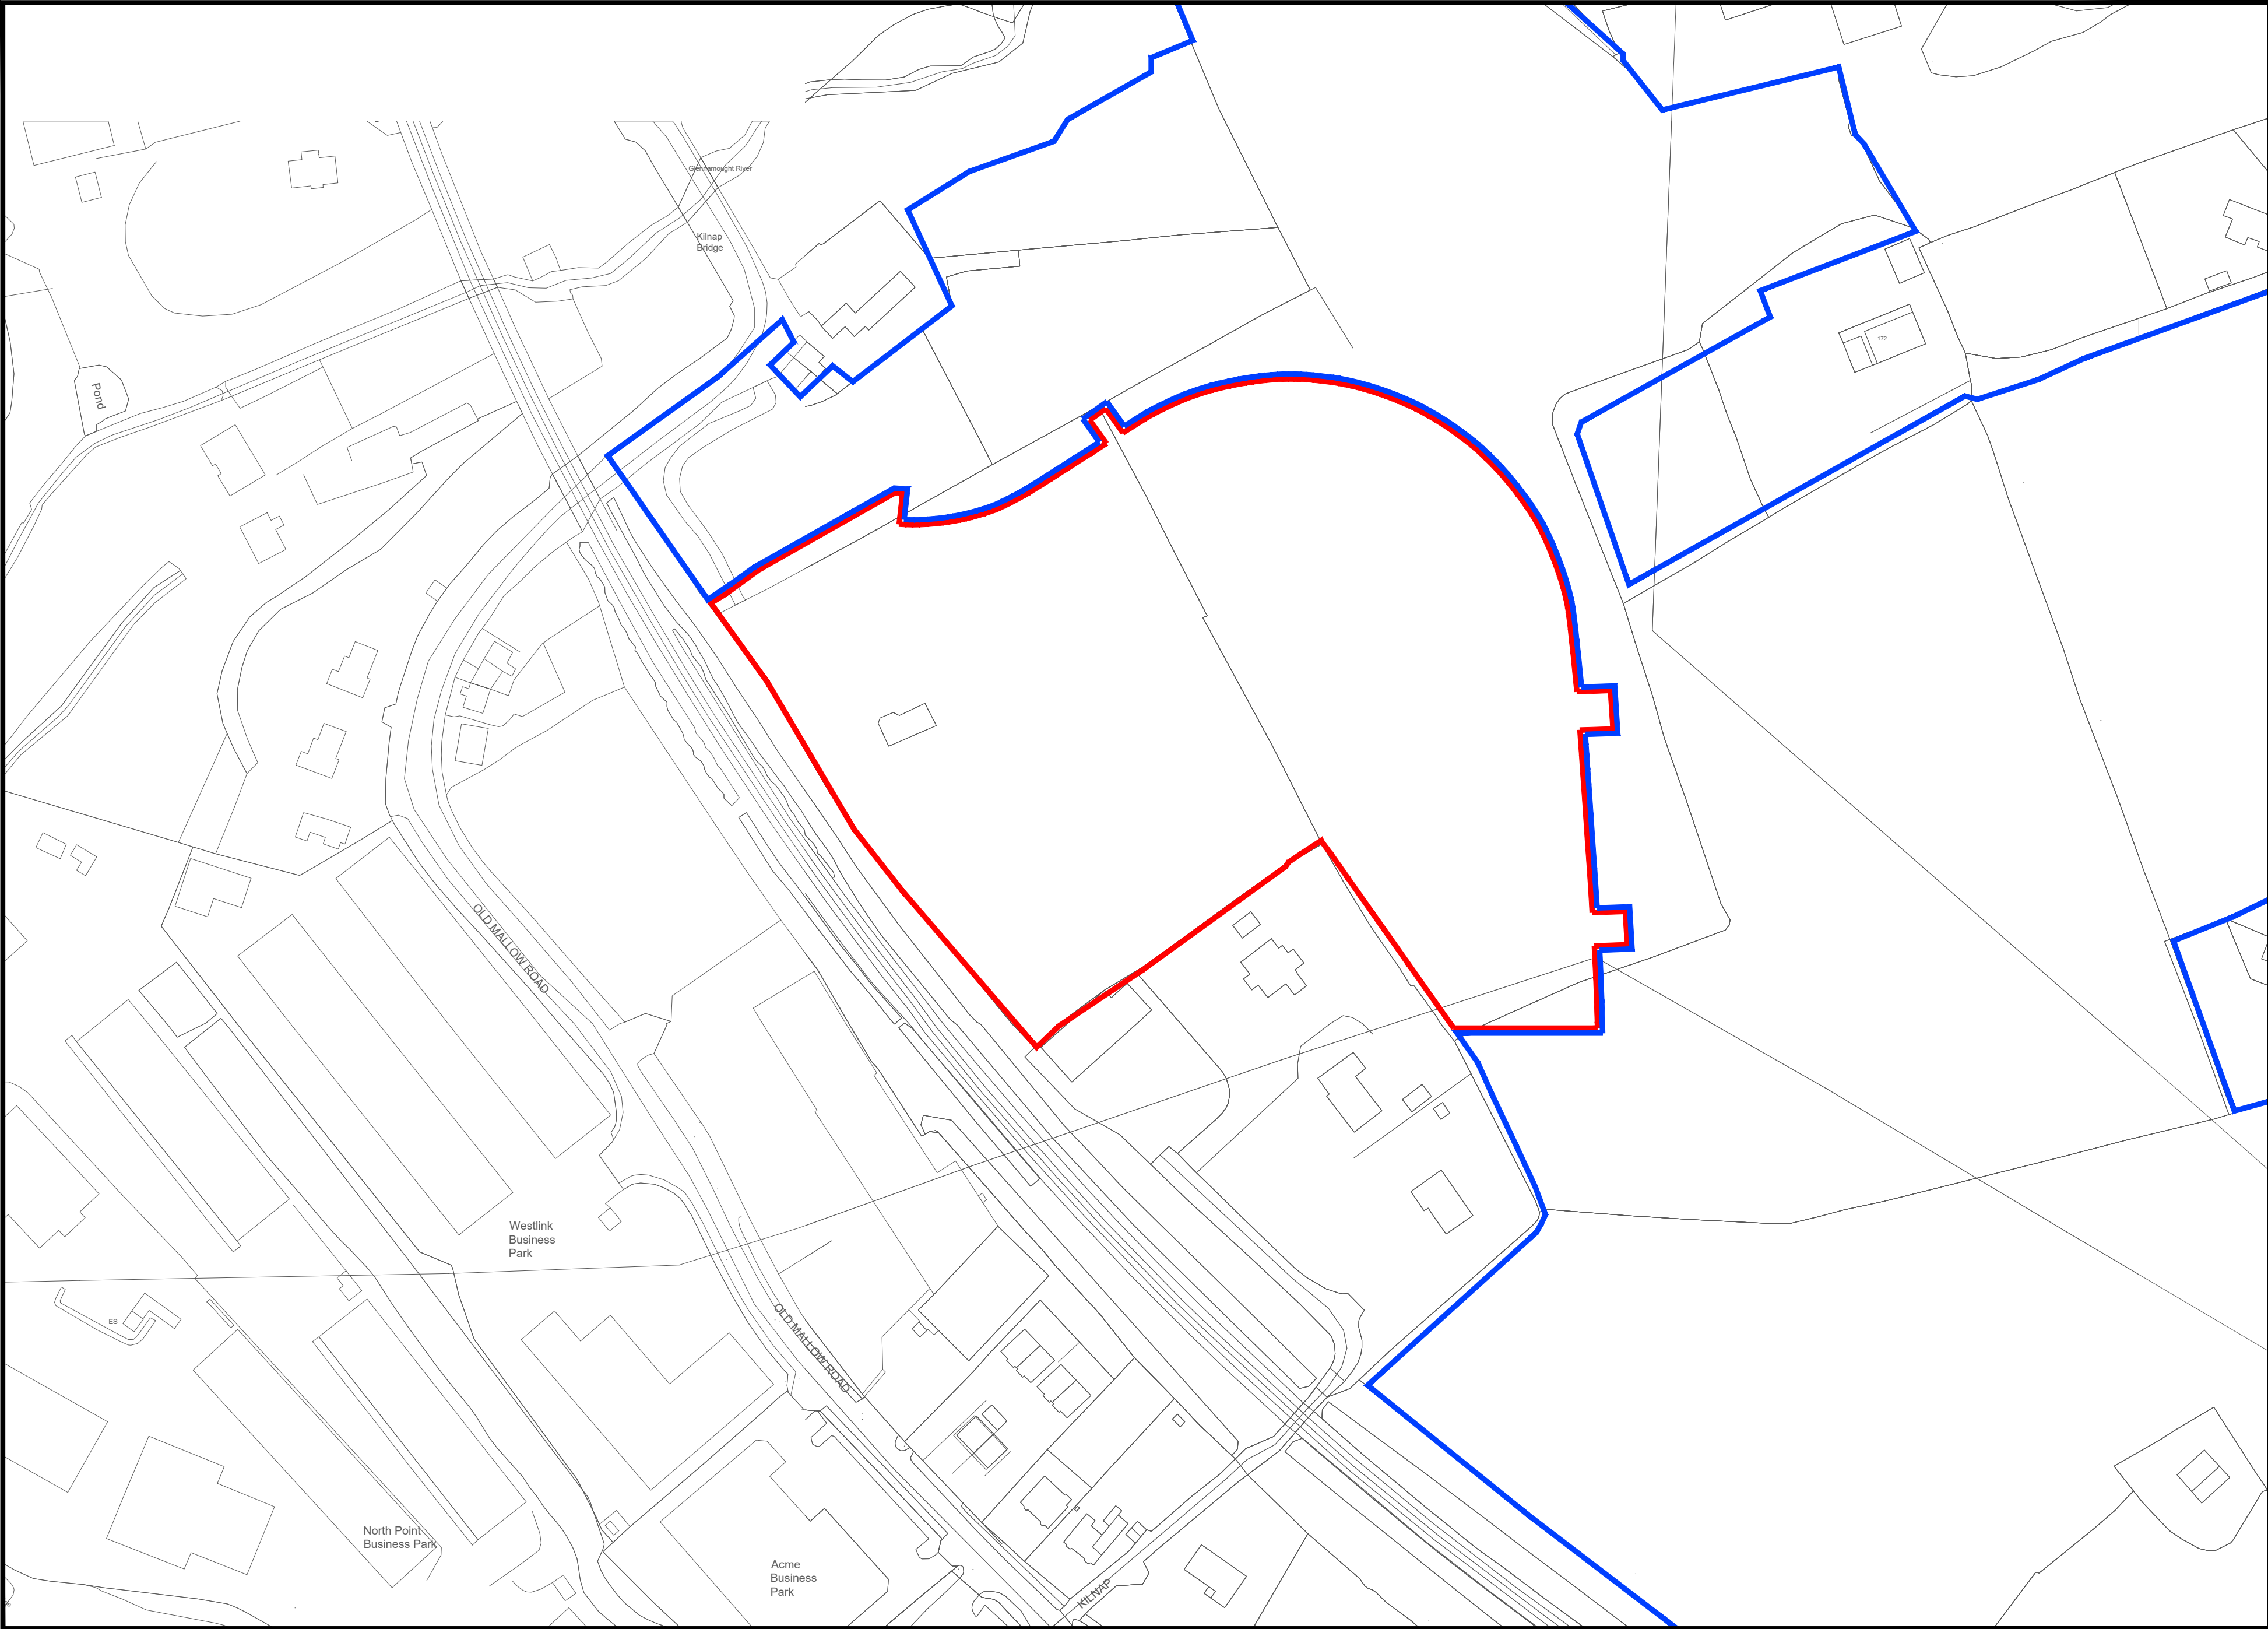

Locality Plan

C	K.M.	L.O.T.	L.O.T.	25.07.24	Issued for Planning	
REV.	DRAWN	CHKD	APPRVD	DATE	DETAILS	

CLIENT	
PROJECT	
Residential Development at Kilnap, Old Whitechurch road	

DRAWING TITLE	
Drawing Index & Locality Plan.	

SHEET	SCALE	PROJECT NO.	DRAWING NO.	STATUS/ISSUE
A1	NTS	6254	0000	C