


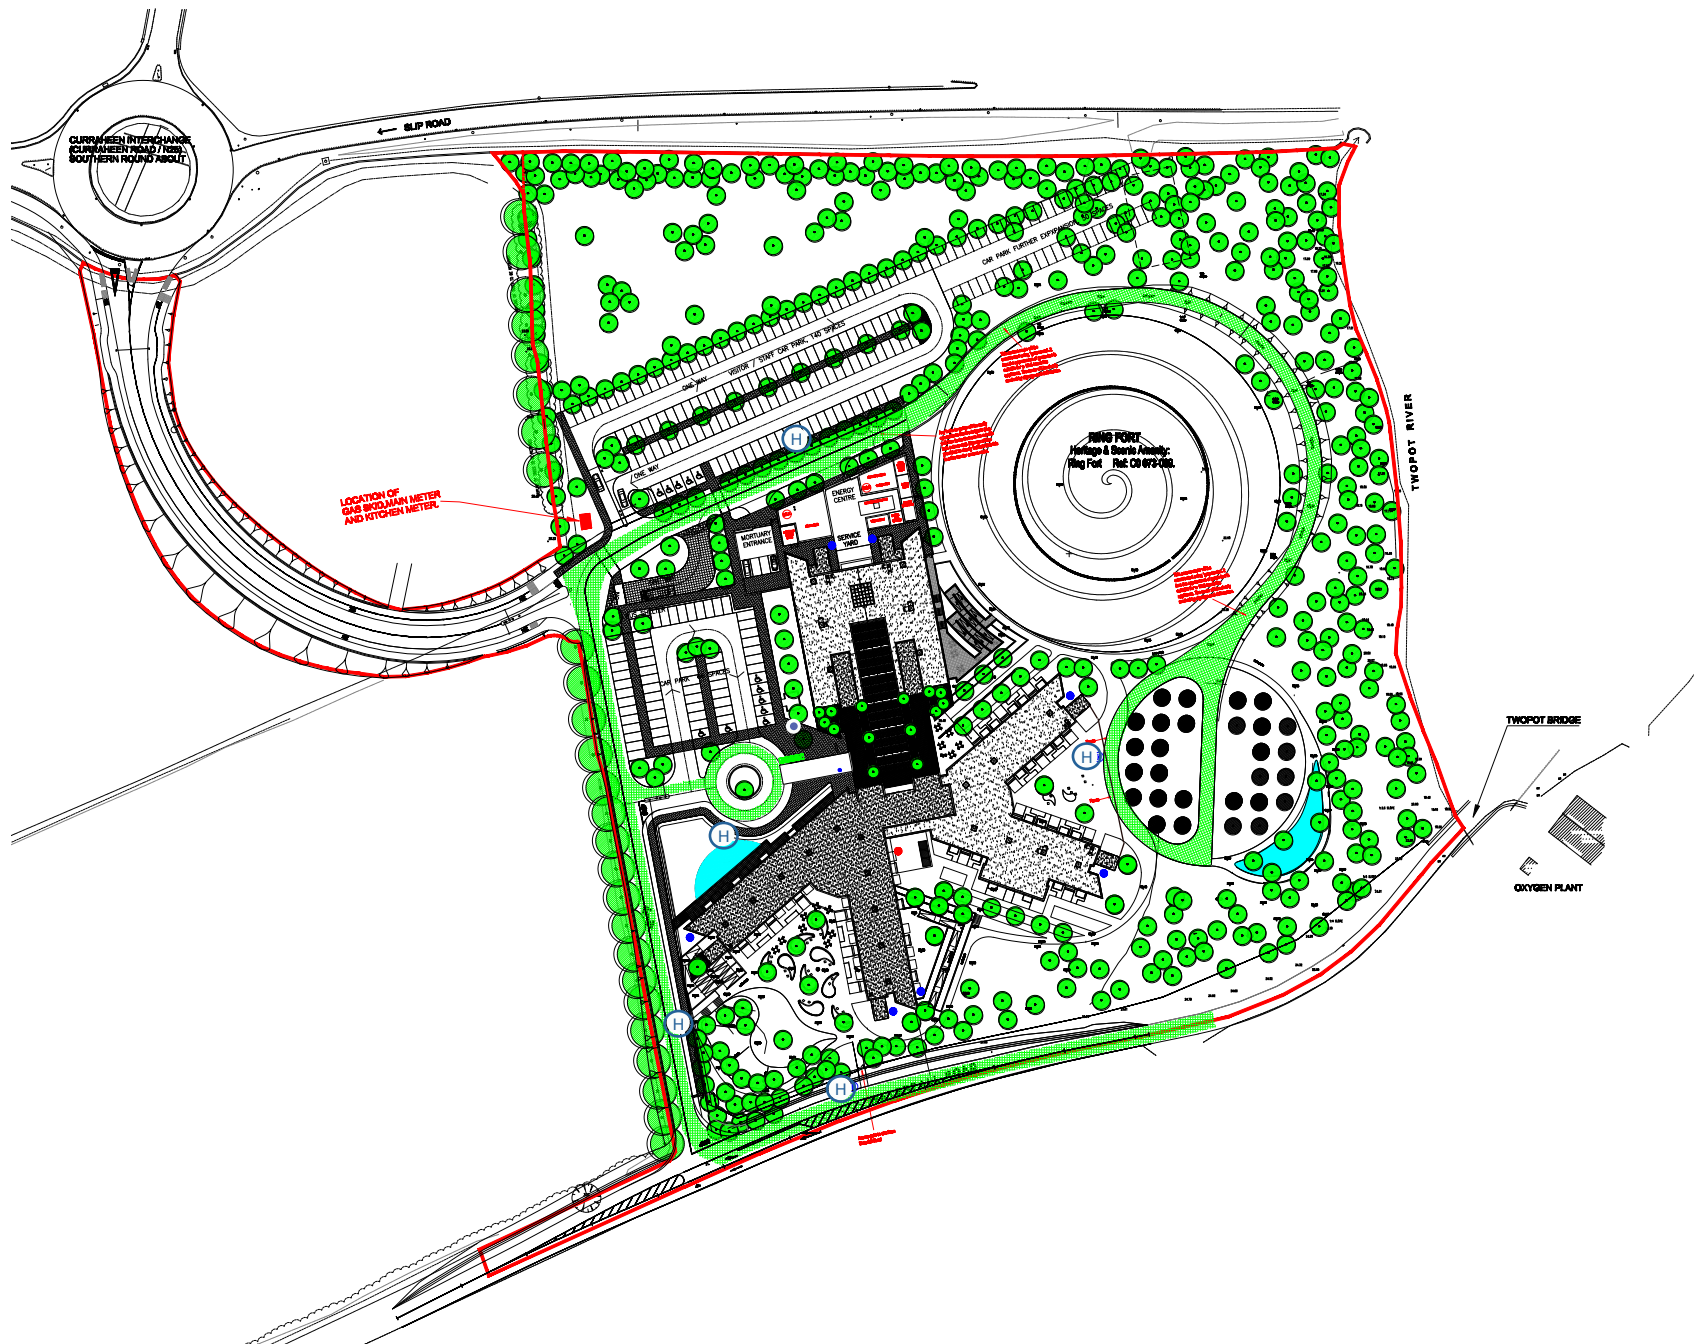

FIRE LEGEND

- Site Boundary
- Access routes for Fire Tender Appliance
- H Fire Hydrant Location
- R Fire resisting doorset achieving 30 minutes fire resistance (integrity)
- Dry Riser Outlet Point
- Dry Riser Inlet Point
- FS Fireman's Switch
- SSV CHP Siam Shut Valve
- OSO OS Shut-Off Valve

SITE PLAN



Fire Engineering Consultants

66 Baggot Street Lower, Dublin 2
 Telephone (01) 661 4925
 Fax (01) 661 4818
 email dublin@jgafire.com

Project: Maymont Hospital & Hospitals
 Commission, Cork

Drawing Title

Site Plan

Scale	Date	Drawing No.	Revision
1:100 @ A0	24/04/14	11-2368-0100	-